


WAYNE STATE UNIVERSITY

Law School Building Media Wall

Detroit, MI

WSU Project Number 049-279772

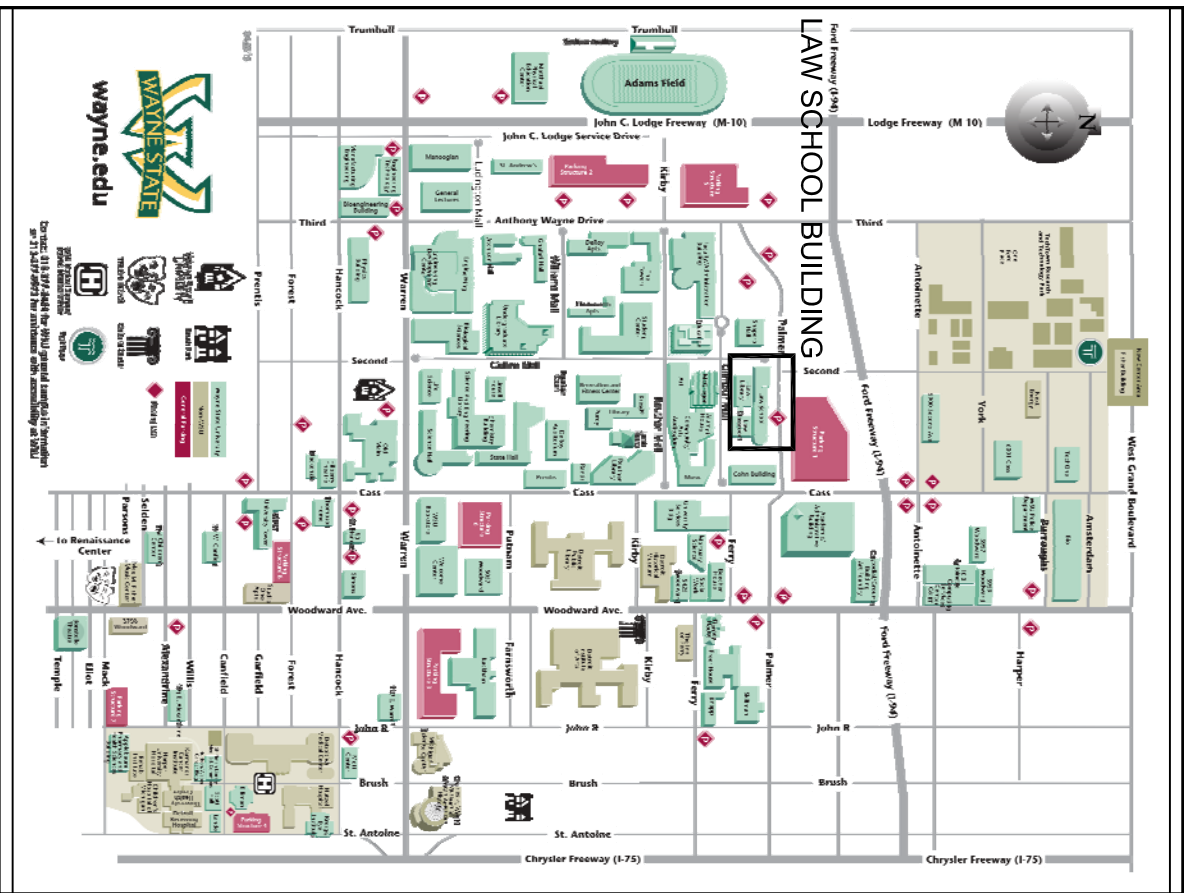

VICINITY MAP – ND SCALE

DRAWING INDEX:

- GENERAL
- G.01 – TITLE SHEET
- ARCHITECTURAL
- A.01 – Floor Plan
- A.02 – Elevations
- FOR REFERENCE ONLY
- A 401 - RCP Lvl I Addtn W REFERENCE ONLY
- E-006 Communication Sys Conduit Raceway Riser Diag REFERENCE ONLY
- E-101 Lvl One Addition West Pwr Sys REFERENCE ONLY

WAYNE STATE
UNIVERSITY

Drawing Title
LAW SCHOOL MEDIA WALL
LAW SCHOOL BUILDING
471 W PALMER AVE.
TITLE SHEET


General Notes

Drawn By		
Checked By		
	BDS	6-9-16
No.	Revision/Issue	Date

From Name and Address
Wayne State University
Facilities Planning and
Management
Design & Construction
Services
5454 Cass Avenue
Detroit, MI 48202

Project Number
049-279772
MEDIA WALL

Date	Sheet
6-9-2016	G.01

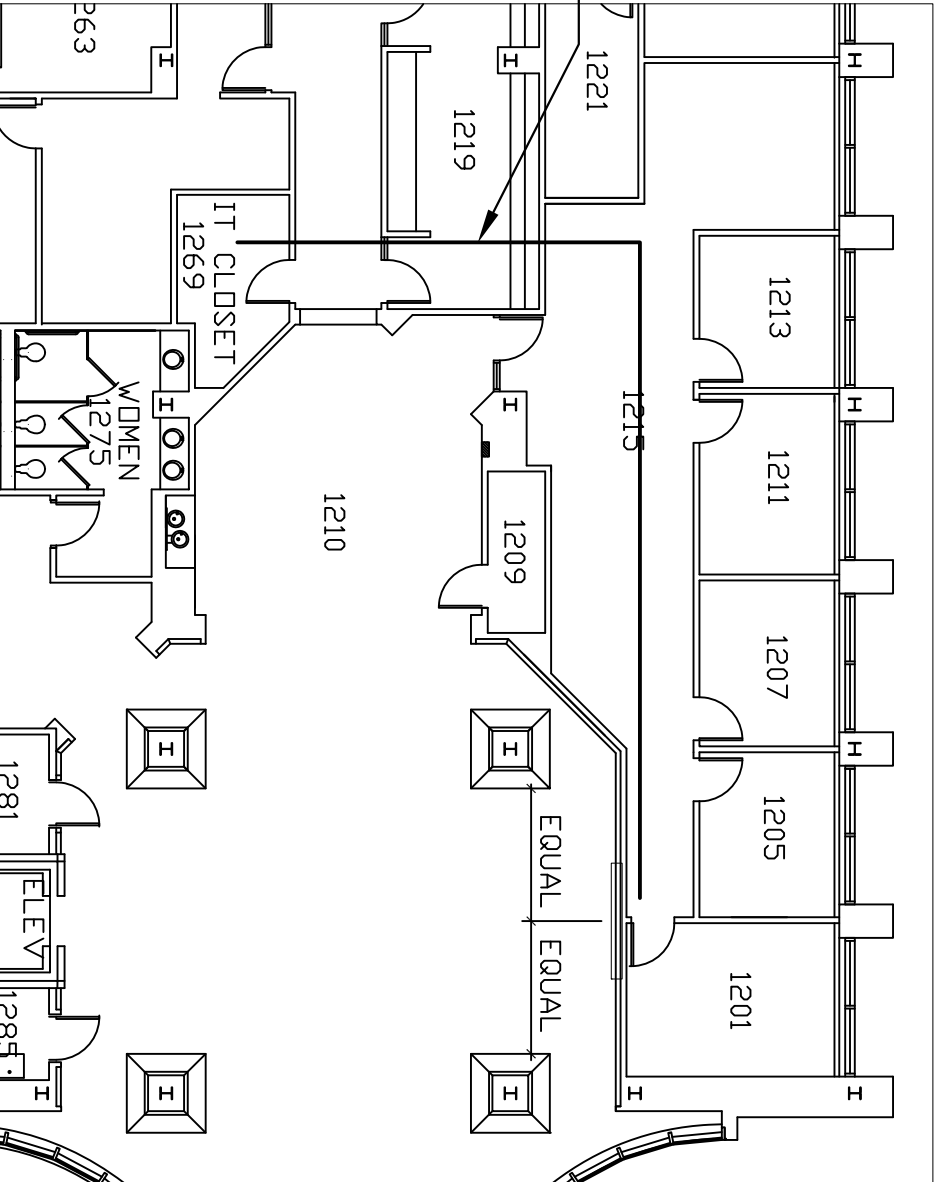


General Notes		
Drawn By CA		
Checked By DB		
2		
1	VIDEO WALL RFP	6/9/16
No.	Revision/Issue	Date

Firm Name and Address Wayne State University Facilities Planning and Management Design & Construction Services 5454 Cass Avenue Detroit, MI 48202	
--	--

Project Number 049-279772
MEDIA WALL

Sheet A.OI
Date 6-9-2016

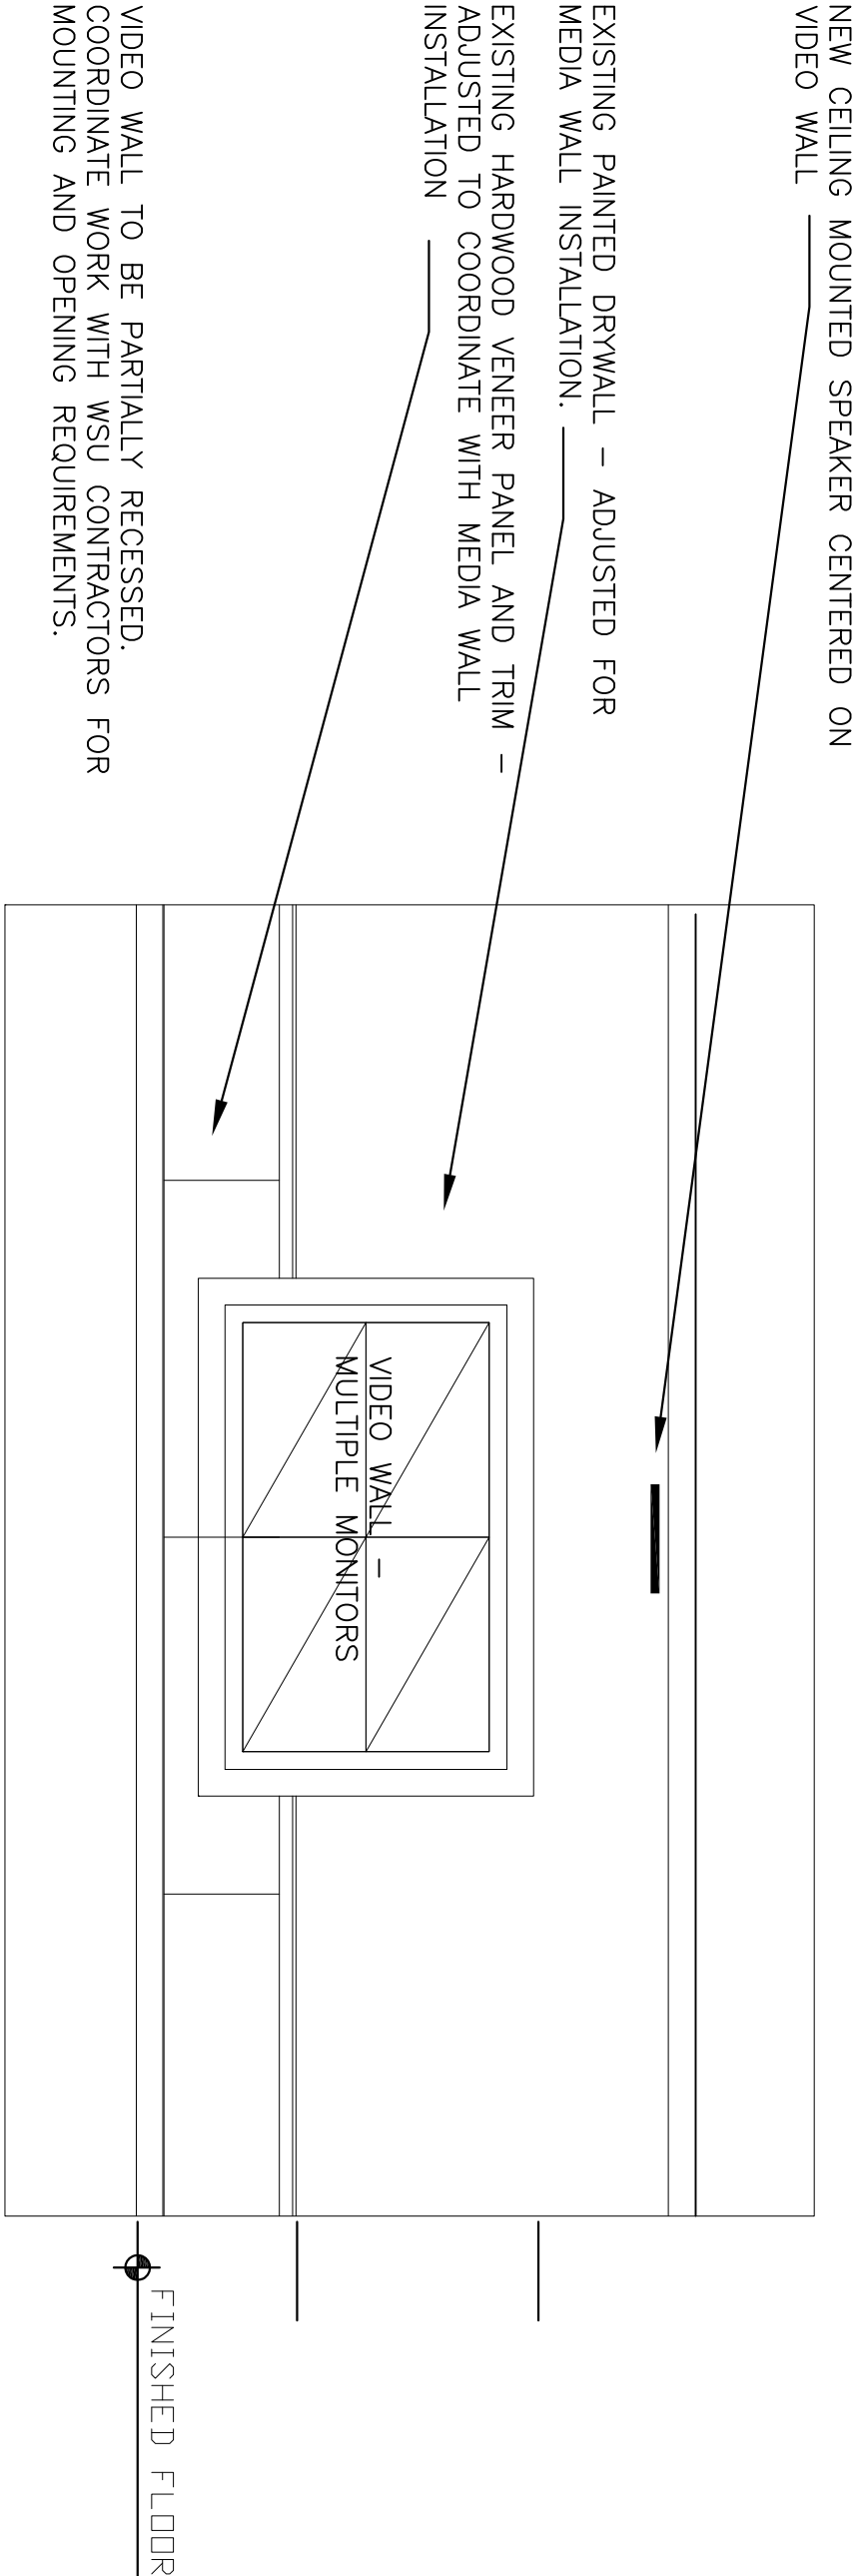

PARTIAL ELEVATION – NO SCALE



EXISTING LOBBY

WAYNE STATE
UNIVERSITY

LAW SCHOOL MEDIA WALL
LAW SCHOOL BUILDING
471 W PALMER AVE.

Elevations


General Notes

Drawn By CA			
Checked By JDB			
2			
1	VIDEO WALL RFP		6/9/16
No.	Revision/Issue	Date	

Firm Name and Address
Wayne State University
Facilities Planning and
Management
Design & Construction
Services
5454 Cass Avenue
Detroit, MI 48202


Project Number
049-279772
MEDIA WALL

Date 6--9--2016	Sheet A.02
--------------------	---------------

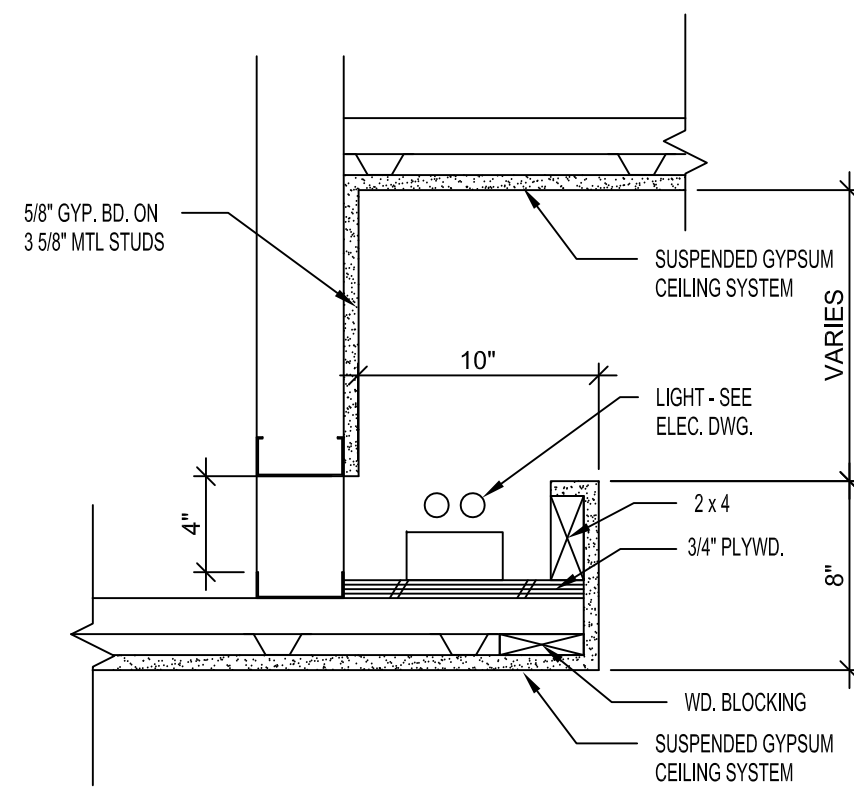

Light Shelf Detail

1
A401
1 1/2"=1'-0"

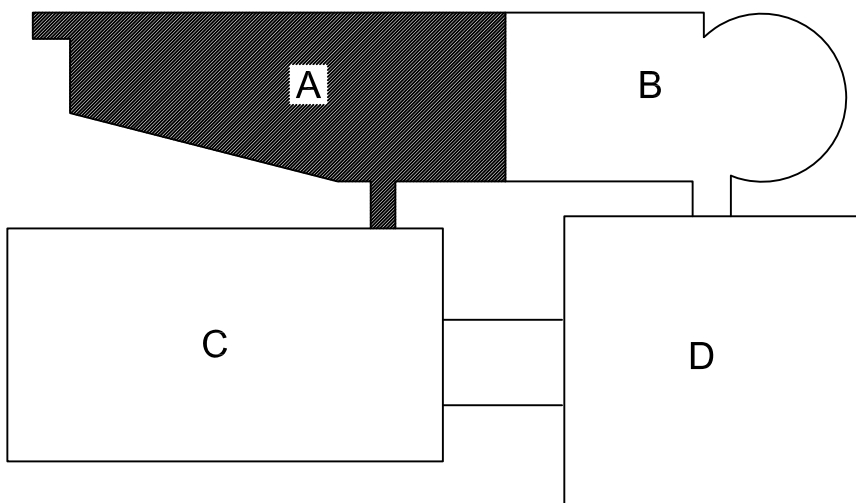

Key Plan
N.T.S.

Key Legend

- 2 x 2 FLOURESCENT FIXTURE
- 2 X 4 FLOURESCENT FIXTURE
- 1 X 4 FLOURESCENT FIXTURE
- 1 X 4 STRIP FLOURESCENT FIXTURE
- RECESSED LIGHT
- WALL MOUNTED LIGHT
- TRACK LIGHT FIXTURE
- HVAC SUPPLY
- RETURN GRILLE
- EXIT LIGHT
- SPEAKER
- WALL MTD. EMERGENCY LIGHT
- ACCESS PANEL
- GYPSUM CEILING
- EXPOSED CONSTRUCTION
- EXTERIOR FINISH CEMENT PANEL SYSTEM

General Notes

- REFER TO MECHANICAL AND ELECTRICAL DRAWINGS FOR LIGHTS, DIFFUSERS AND GRILLE TYPES AND FIRE SPRINKLERS. REFER TO THIS DRAWING FOR LOCATIONS OF LIGHT FIXTURES AND GRILLES.
- REFER TO THE ROOM FINISH SCHEDULE FOR CEILING FINISHES AND HEIGHTS NOT INDICATED.
- LIGHT FIXTURES IN LAY IN CEILING GRID ARE TO BE CENTERED.
- FINAL LOCATION OF FIRE SPRINKLERS TO BE COORDINATED TO ALIGN WITH OR BE CENTERED ON GRID AND CENTERLINE OF LIGHTS AND CEILING GRID. ALL LOCATIONS TO BE SUBMITTED FOR REVIEW AND APPROVAL OF LOCATION.
- TWENTY-EIGHT 12" x 12" PLUMBING WALL ACCESS PANELS TO BE PROVIDED - LOCATIONS TO BE DETERMINED.
- TWENTY - FOUR 18" x 18" MECHANICAL CEILING ACCESS PANELS TO BE PROVIDED - LOCATIONS TO BE DETERMINED.
- ALL SOFFIT HEIGHTS ARE TO BE 7'-2" A.F.F. UNLESS OTHERWISE NOTED.

Keynotes - Drawing A401

- EXTERIOR FINISH CEMENT PANEL SYSTEM


Room Legend

Room No.	Name	Room No.	Name
101	West Lobby	130	Corridor
102	Admissions	131	Student Office
103	Admissions Office	132	Academic Affairs Office
104	Admissions Office	133	Academic Affairs Support
105	Admissions Office	135	Support Services Office
106	Financial Aid	136	Support Services Office
107	Financial Aid	138	Comp Res Lending Library
108	Financial Aid	139	Career Services
109	Copy	140	Voice/Data
110	Electrical	141	Career Services Office
112	Record/Regist Storage	142	Career Services Office
113	Record/Regist	143	Career Services Office
114	Record/Regist Office	144	Files
115	Mall	145	Women
116	Student Offices	146	Men
117	Student Offices	147	Corridor
118	Student Offices	148	Corridor
119	Student Offices	149	Elevator Equip
120	Student Offices	150	Stair No. 2
121	Student Offices	151	Janitor's Closet
122	Student Offices		
123	Student Offices		
124	Student Offices		
125	Corridor		
126	Mechanical		
127	Name		
128	Name		

Wayne State
University
Law School
Expansion

Reflected Ceiling Plan
Level One Addition - W

DRAWN	dg
CHECKED	xx
APPROVED	xx
APPROVED FOR CONSTRUCTION	xx
PLUT DATE	10.4.99
SCALE	1/8" = 1'-0"
DSA PROJECT NO	99026
DRAWING NO	A401

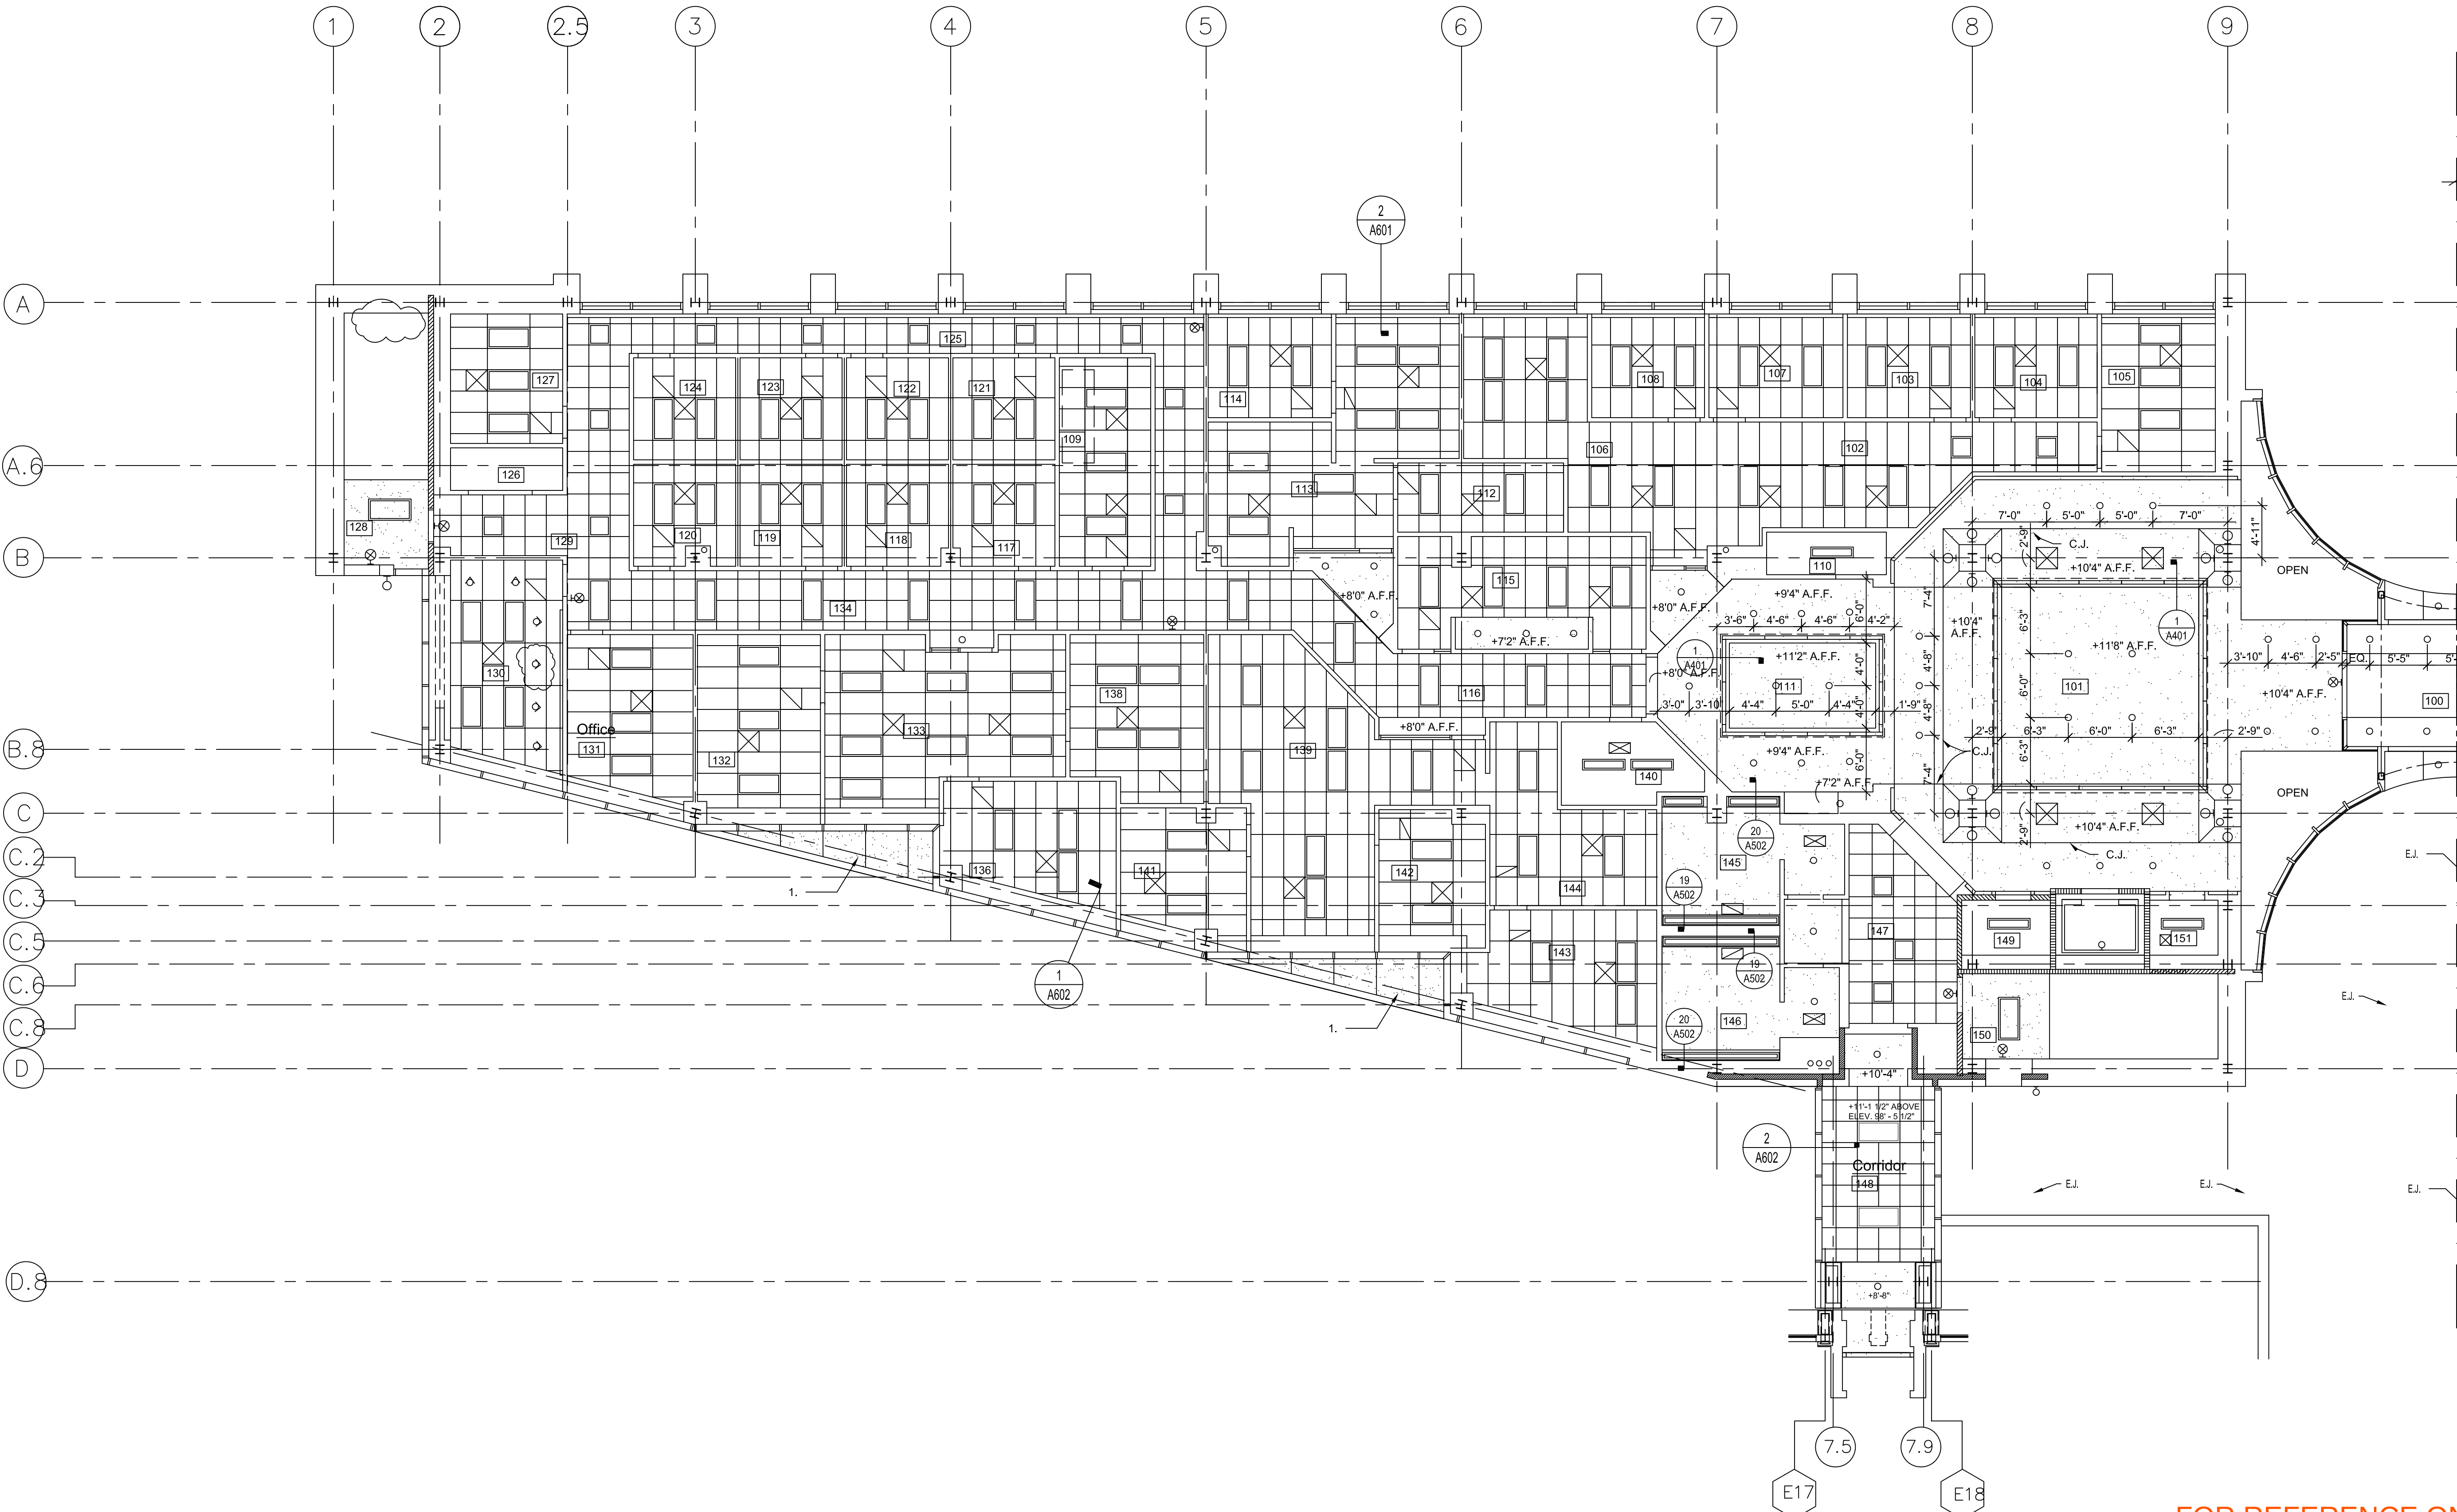

FOR REFERENCE ONLY

Reflected Ceiling Plan
Level One Addition West
1/8"=1'-0"




- TYPICAL MDF ROOM
NOT TO SCALE

- COMMUNICATION SYSTEM CONDUIT RACEWAY RISER DIAGRAM
NOT TO SCALE

Communication System Conduit Raceway Riser Diagram

	DiClemente Siegel Design Inc. 28105 Greenfield Road, Southfield, Michigan 48076-3048 248.569.1430 Fax 248.569.0096	Project No. 98-4811
		ACADFile 4811E006.DWG


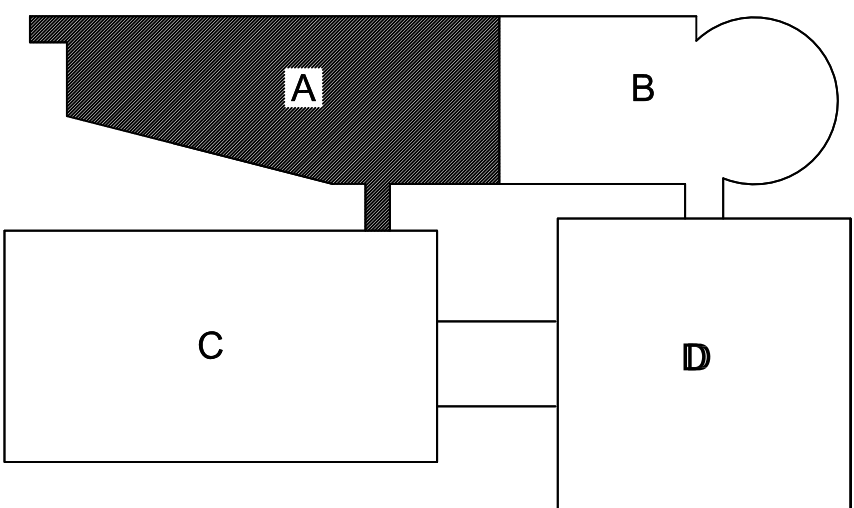


KEY PLAN
NOT TO SCALE


DSA
ARCHITECTS PLANNERS

Duce Simmons Associates
2100 West Big Beaver Rd. Suite 214
Troy, Michigan 48064
Phone 248.816.0510 Fax 248.816.6514

CONSULTANTS

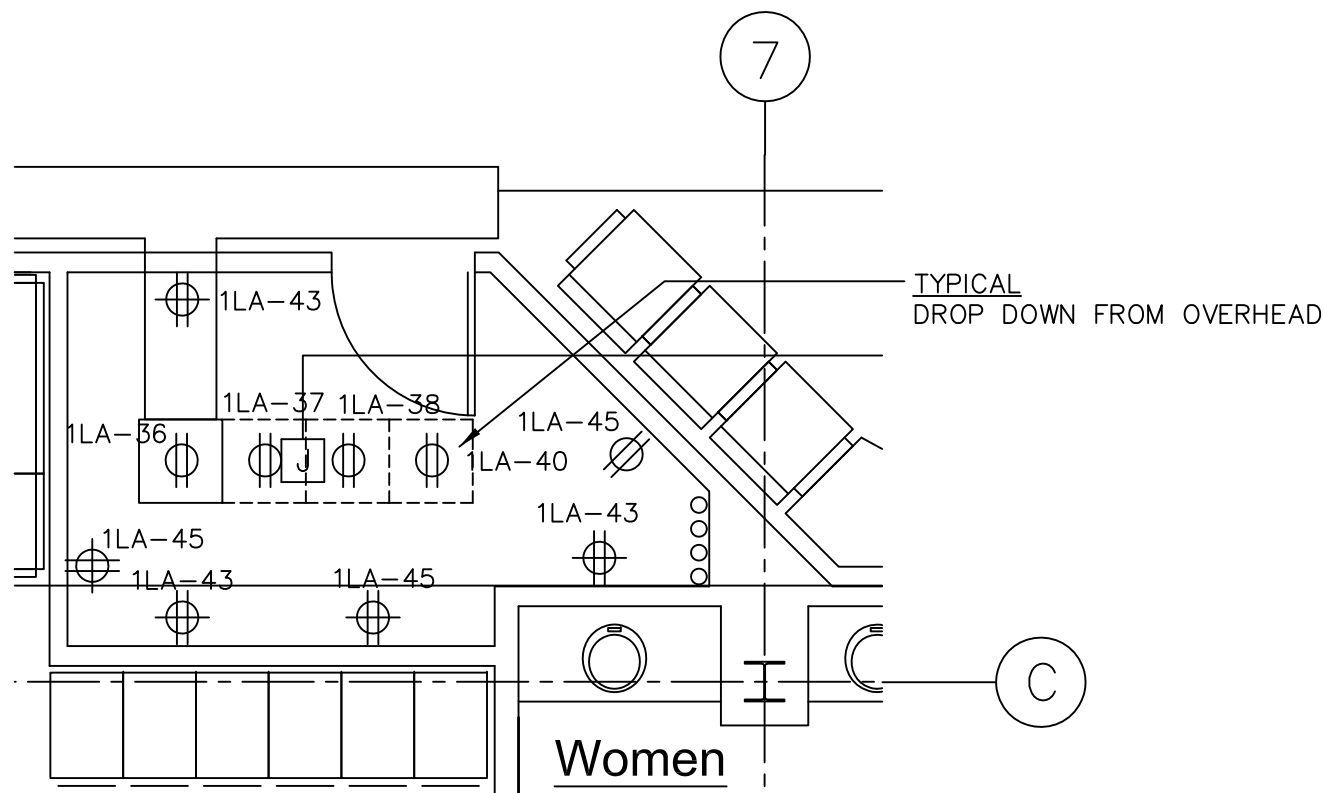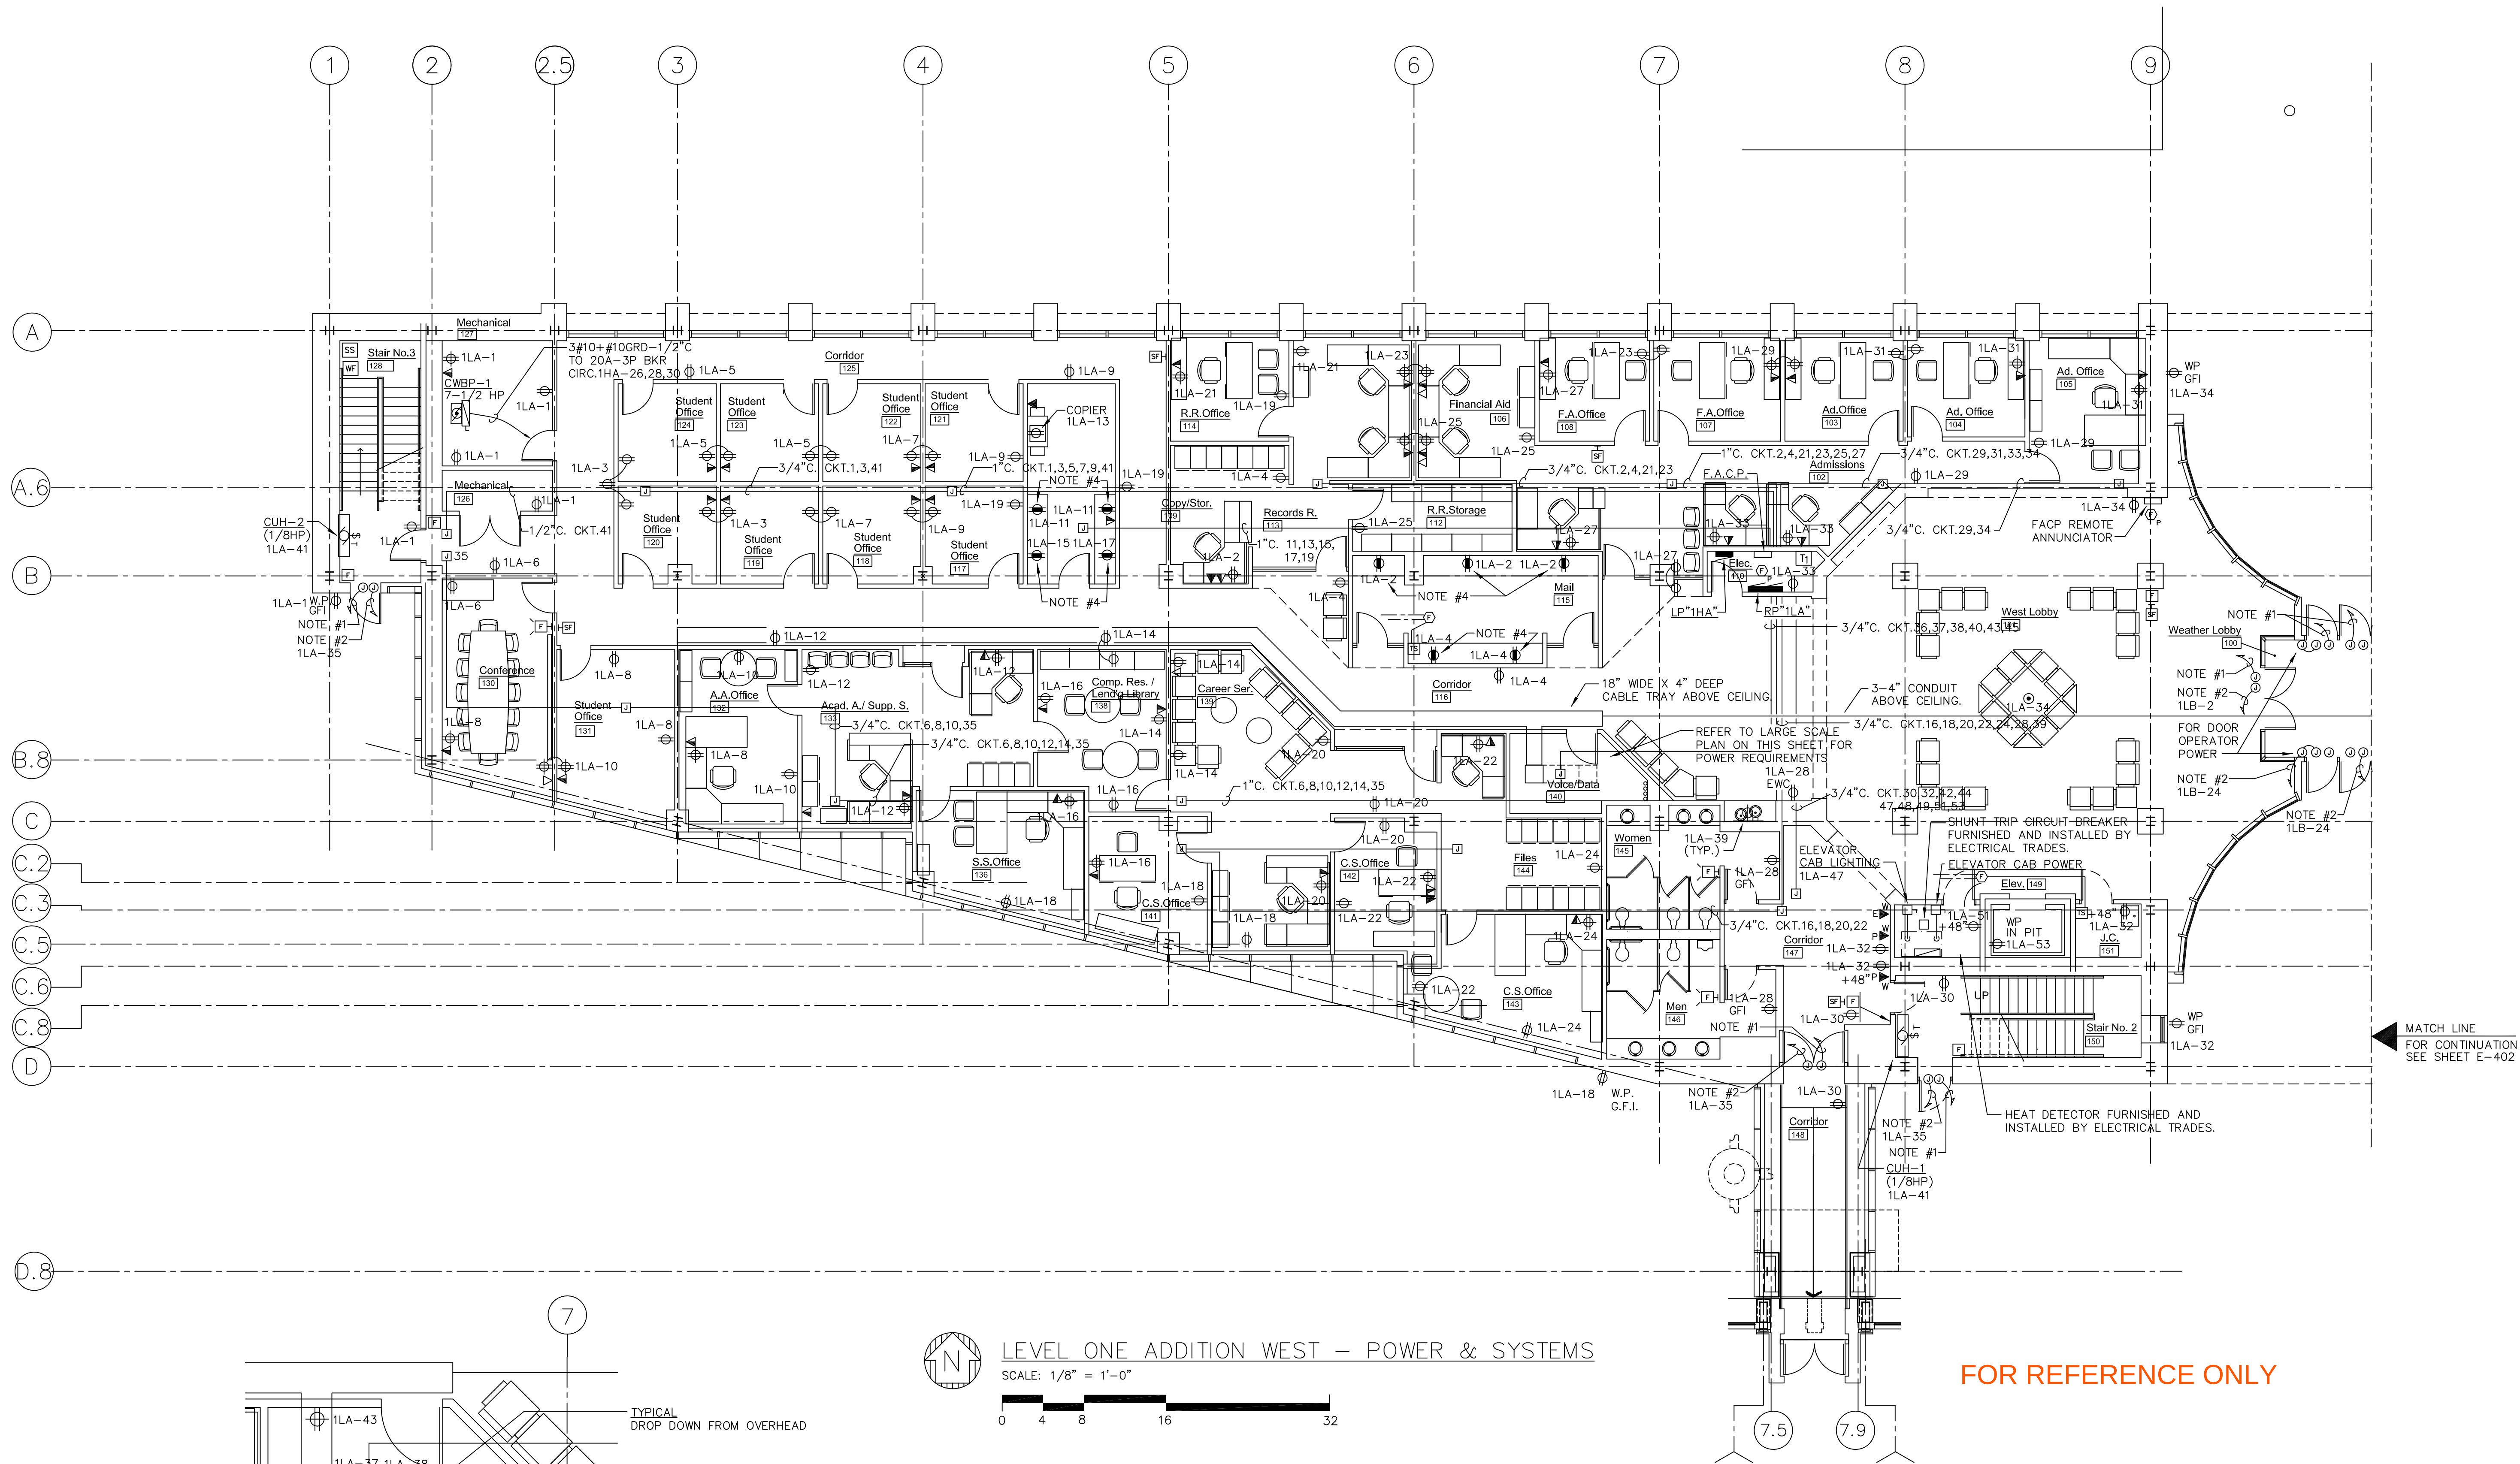

IDF ROOM #140 — POWER & SYSTEMS
SCALE: 1/4" = 1'-0"

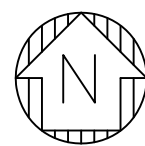

LEVEL ONE ADDITION WEST — POWER & SYSTEMS

SCALE: 1/8" = 1'-0"



NOTES:

- 1" CONDUIT, WITH PULL WIRE, UP TO SECURITY AREA IN VOICE/DATA ROOM #215
- 2#12+1#12 GRD. — 1/2"C. CIRCUIT AS INDICATED.
- IN ADDITION TO DOORS INDICATED ON PLAN, ELECTRICAL CONTRACTOR IS TO PROVIDE AND INSTALL 120VAC CONDUIT, BOXES, ETC. ON ALL DOORS AS INDICATED ON ARCHITECTURAL DOOR HARDWARE SCHEDULE.
- OUTLET TO BE MOUNTED ABOVE COUNTER AT 38" A.F.F


FOR REFERENCE ONLY

+ RECORD DRAWING	8.31.01
+ AS BUILT	4.6.01
+ CCD 030	8.24.00
+ Bulletin No. Nineteen	8.2.00
+ CCD 024	7.17.00
+ Bulletin No. Fifteen	6.12.00
+ Bulletin No. Thirteen	4.26.00
+ Bulletin Eleven	3.3.00
+ SCS Addendum #1	2.21.00
+ Bulletin No. Ten	2.11.00
+ SCS BIDS	1.31.00
+ Bulletin Eight	11.3.99
+ Bid Package Two	8.2.99
+ Bid Package Two	7.19.99
+ GMP Final Submittal	4.7.99
+ GMP Submittal	2.23.99
Issued:	Date:

Wayne State
University
Law School
Expansion

Level One Addition
West Power & Sytems

DRAWN	SDH
CHECKED	RCE
APPROVED	
APPROVED FOR CONSTR.	
PLOT DATE	
SCALE	1/8" = 1'-0"
DSA PROJECT NO	99026
DRAWING NO	E-101

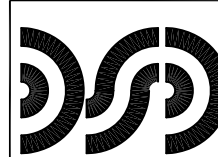

DiClemente Siegel Design Inc.
23105 Greenfield Road, Southfield, Michigan 48076-3046
248.569.1430 Fax 248.569.0096

Project No.
98-4811
ACADFile
4811E101.DWG